



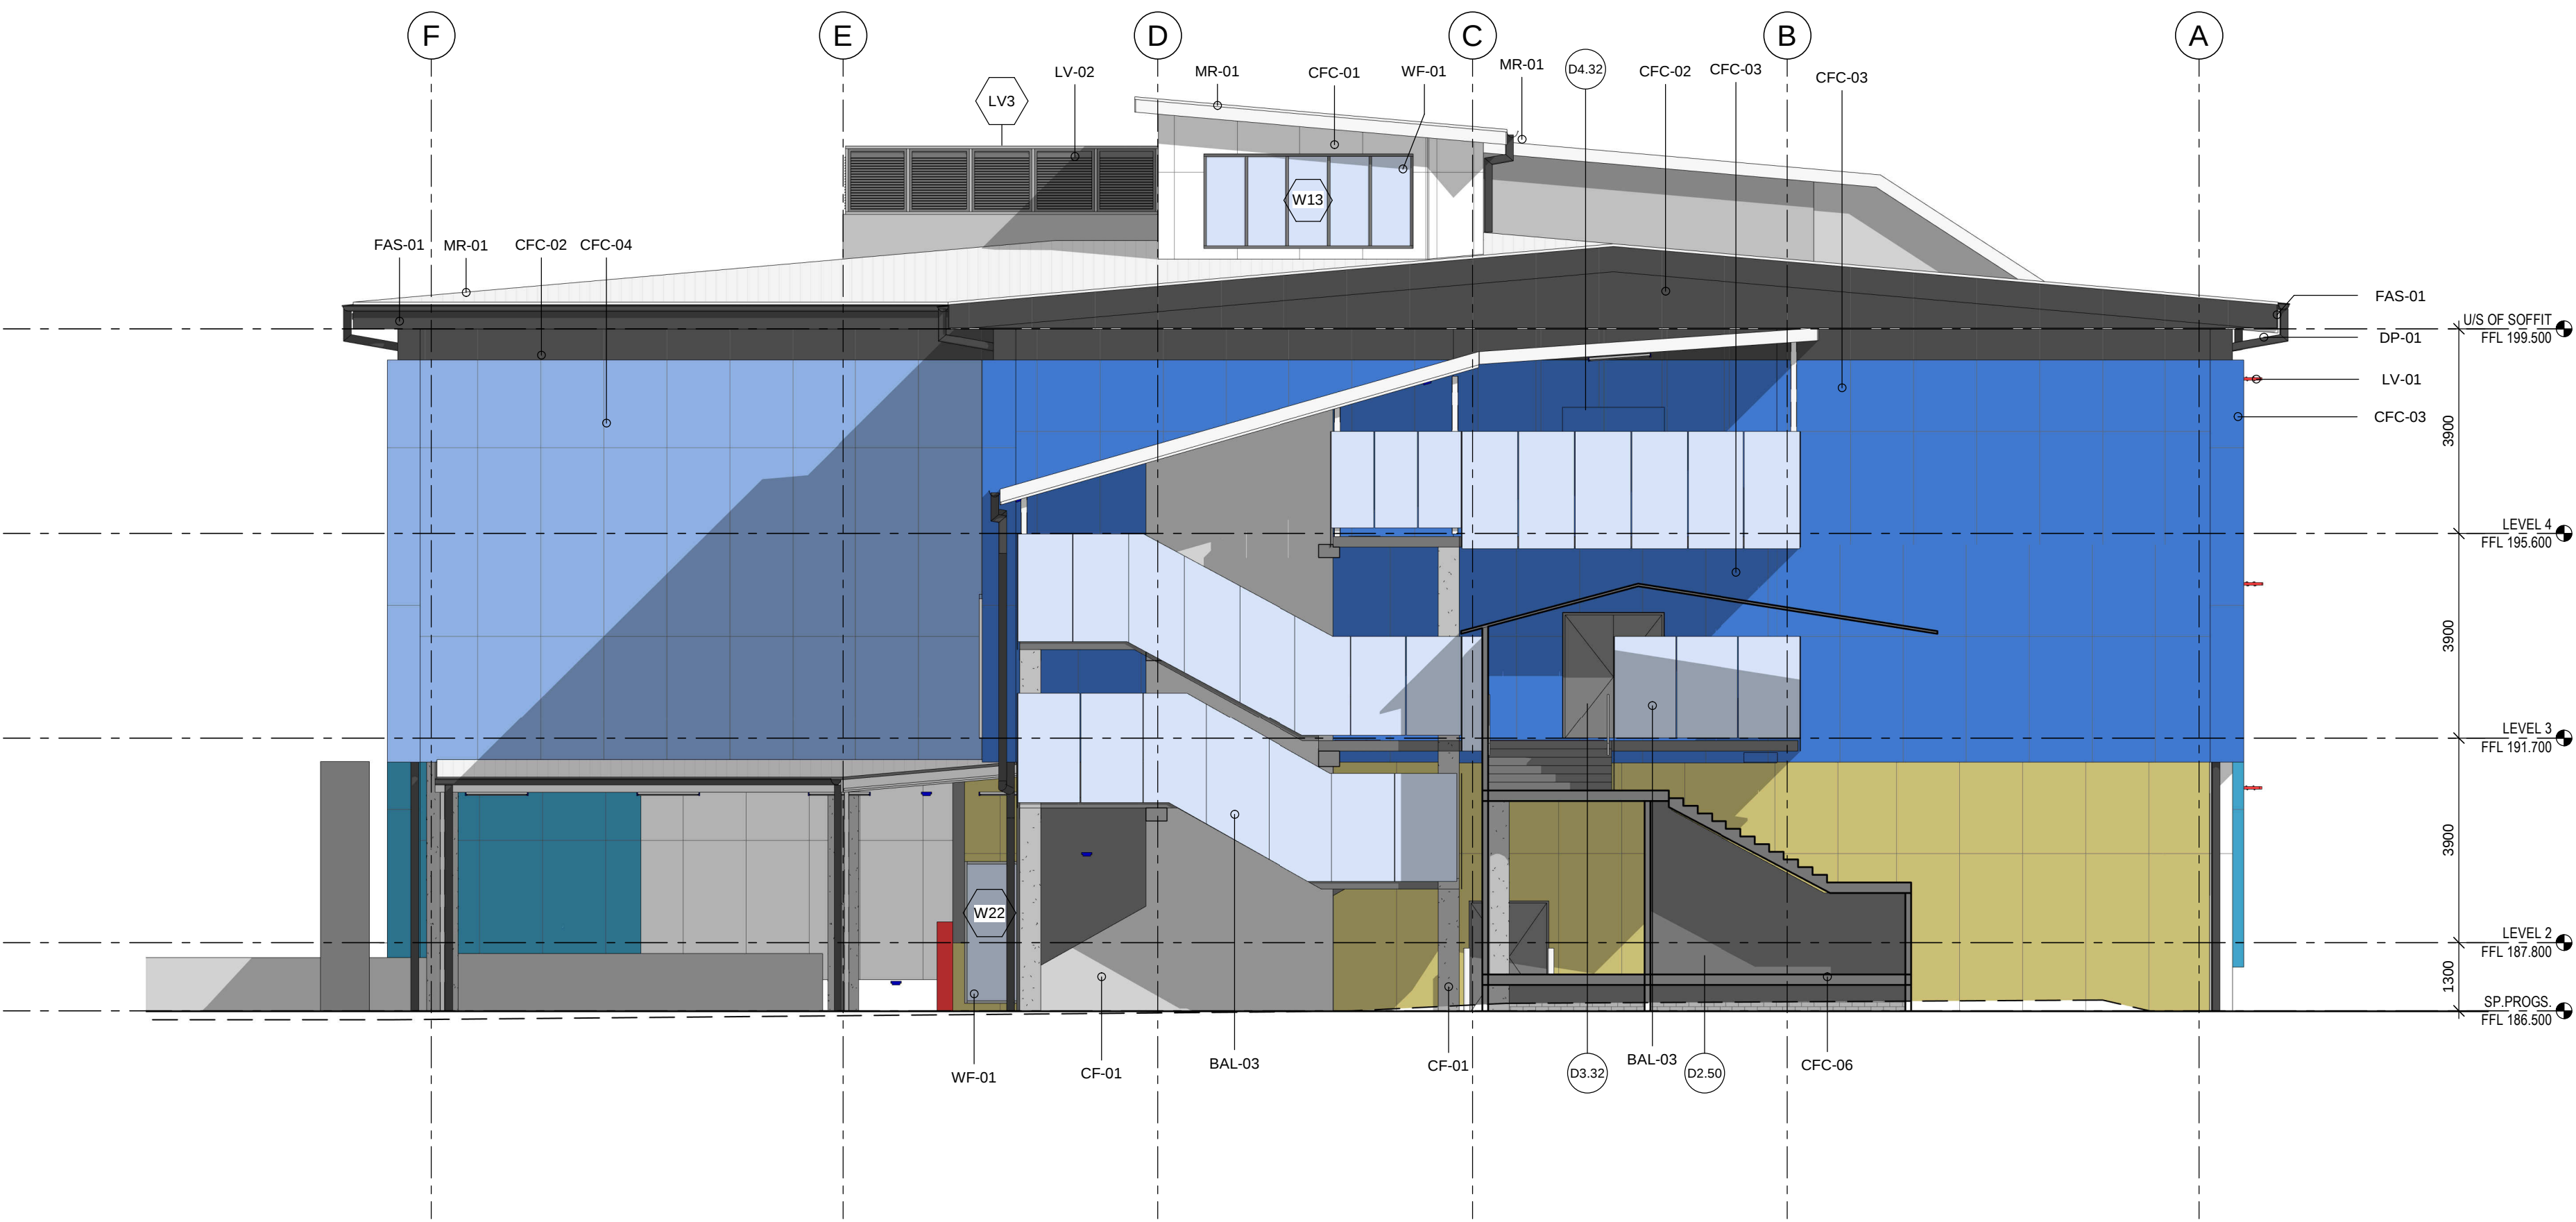


1 East Elevation
1 : 100

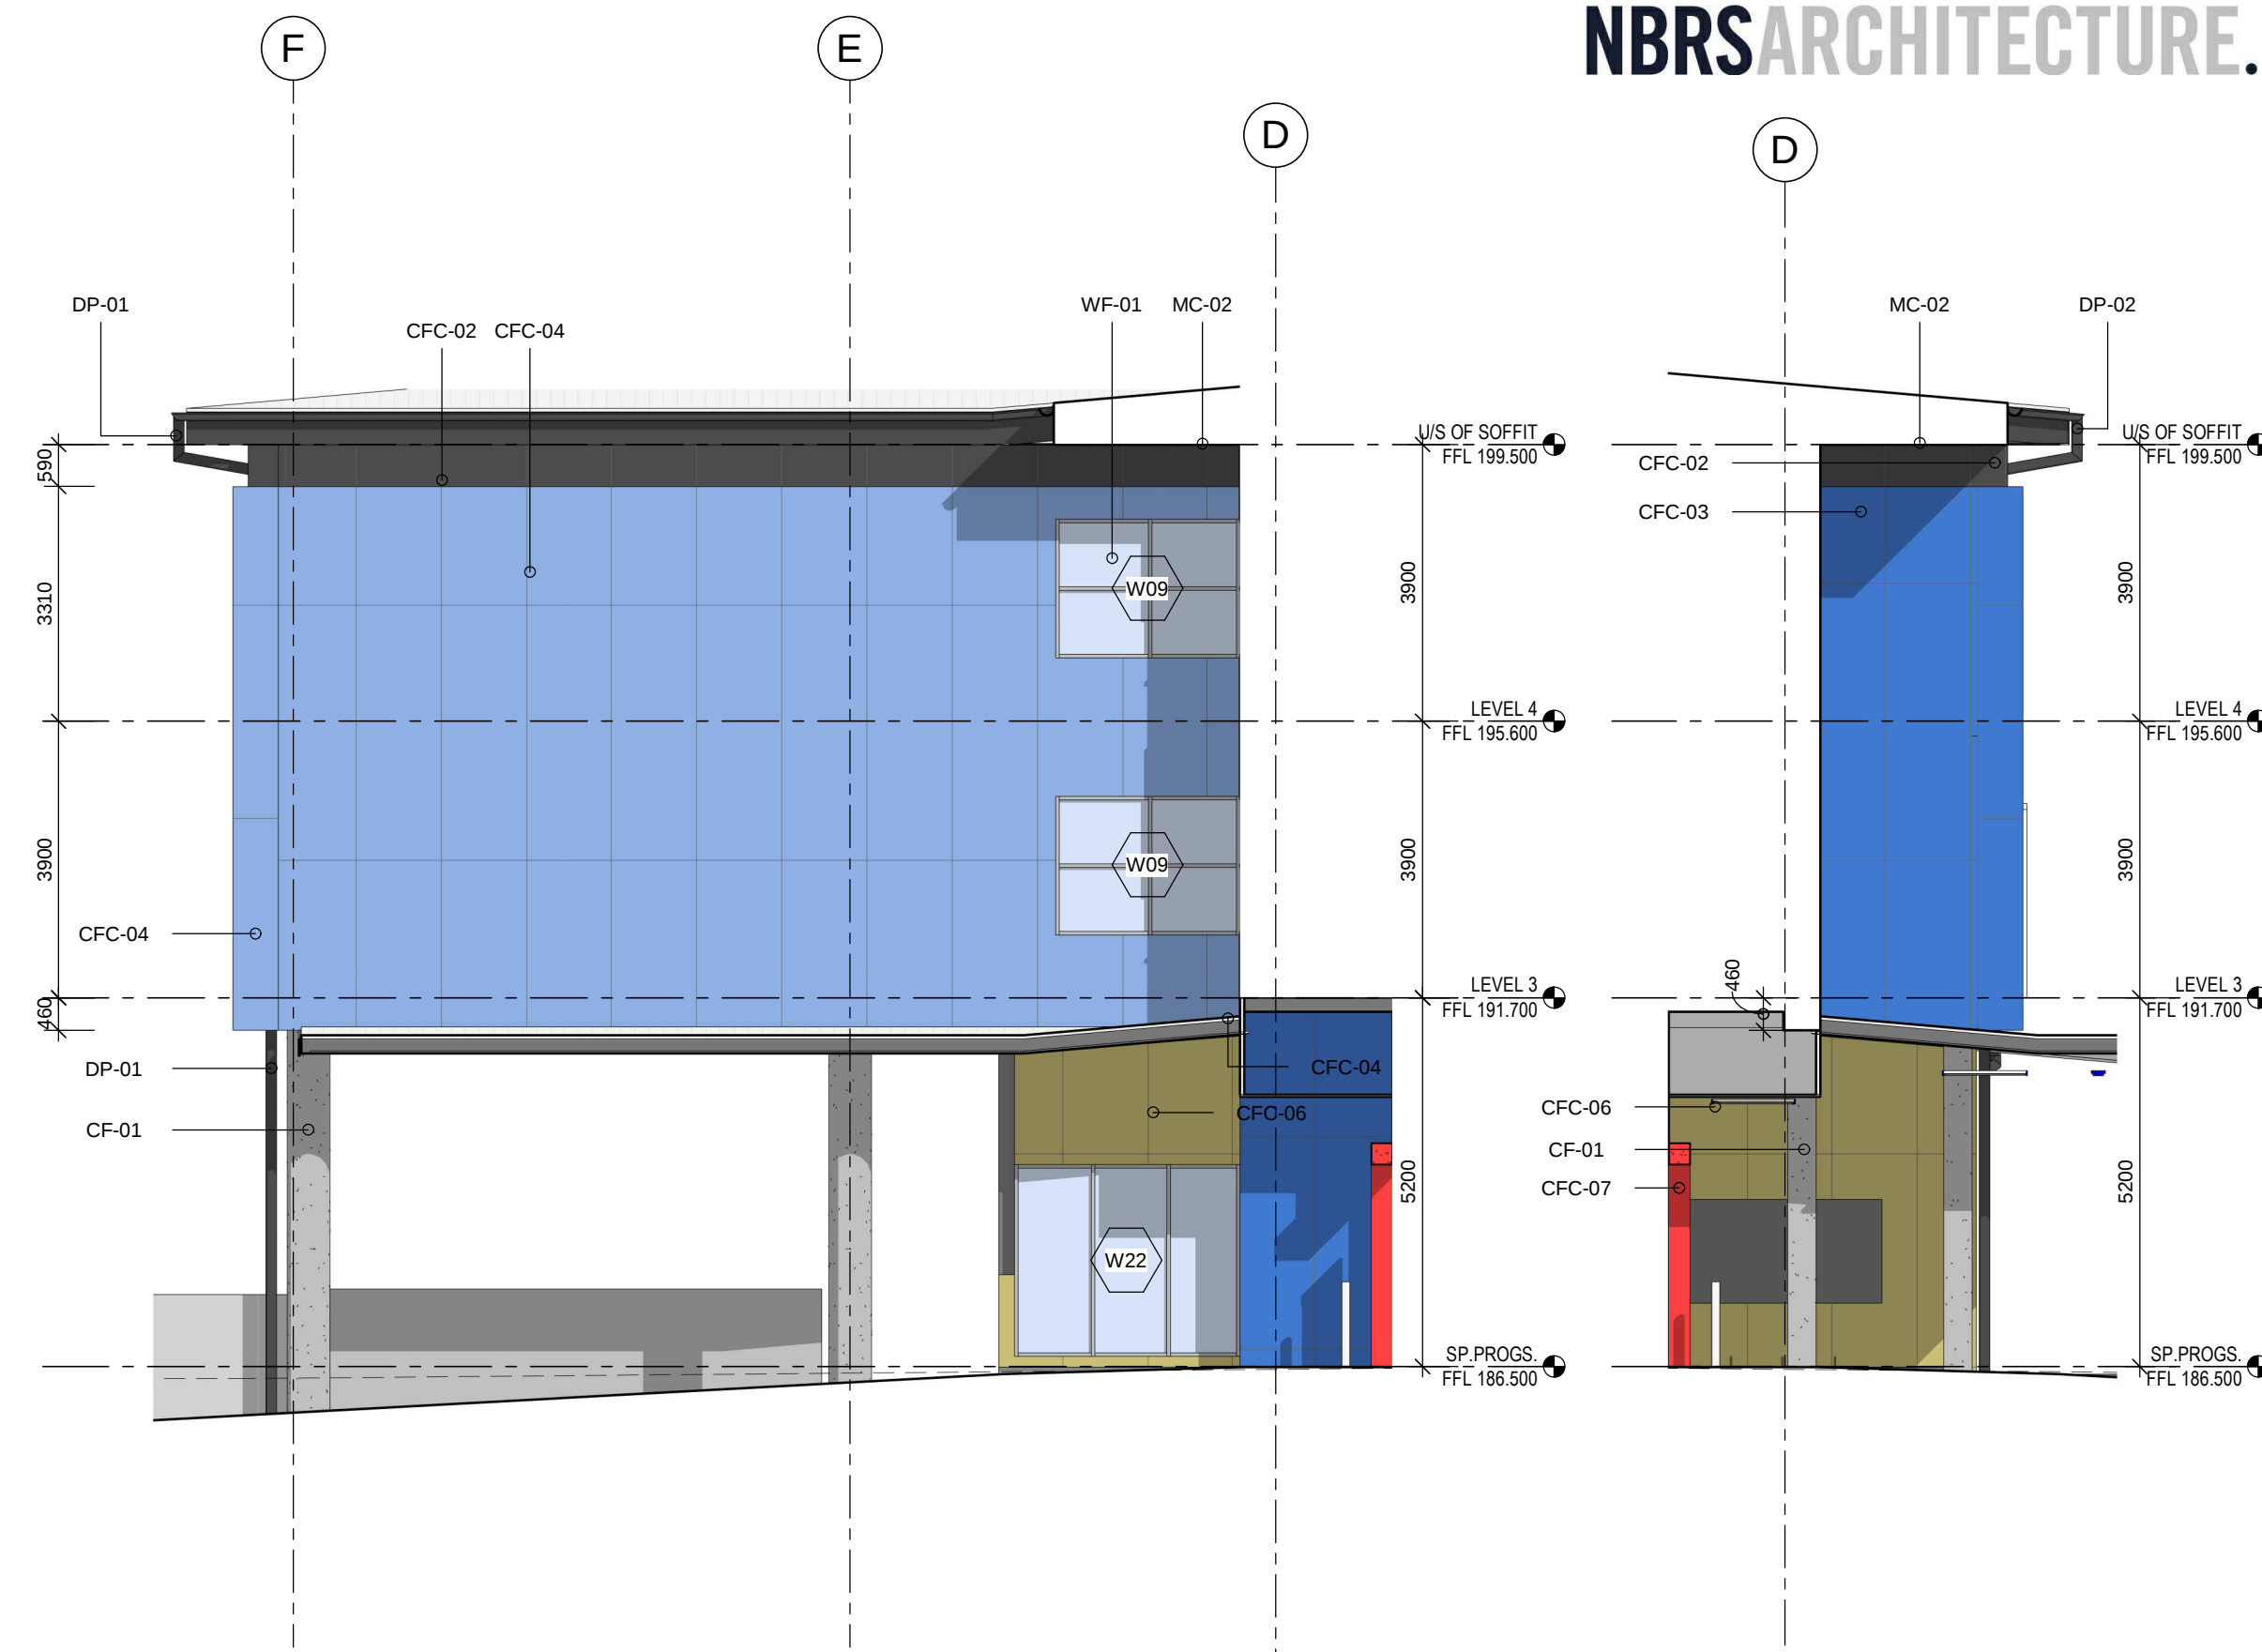


3 East Elevation - Grid 8
1 : 100

4 West Elevation - Grid 9
1 : 100

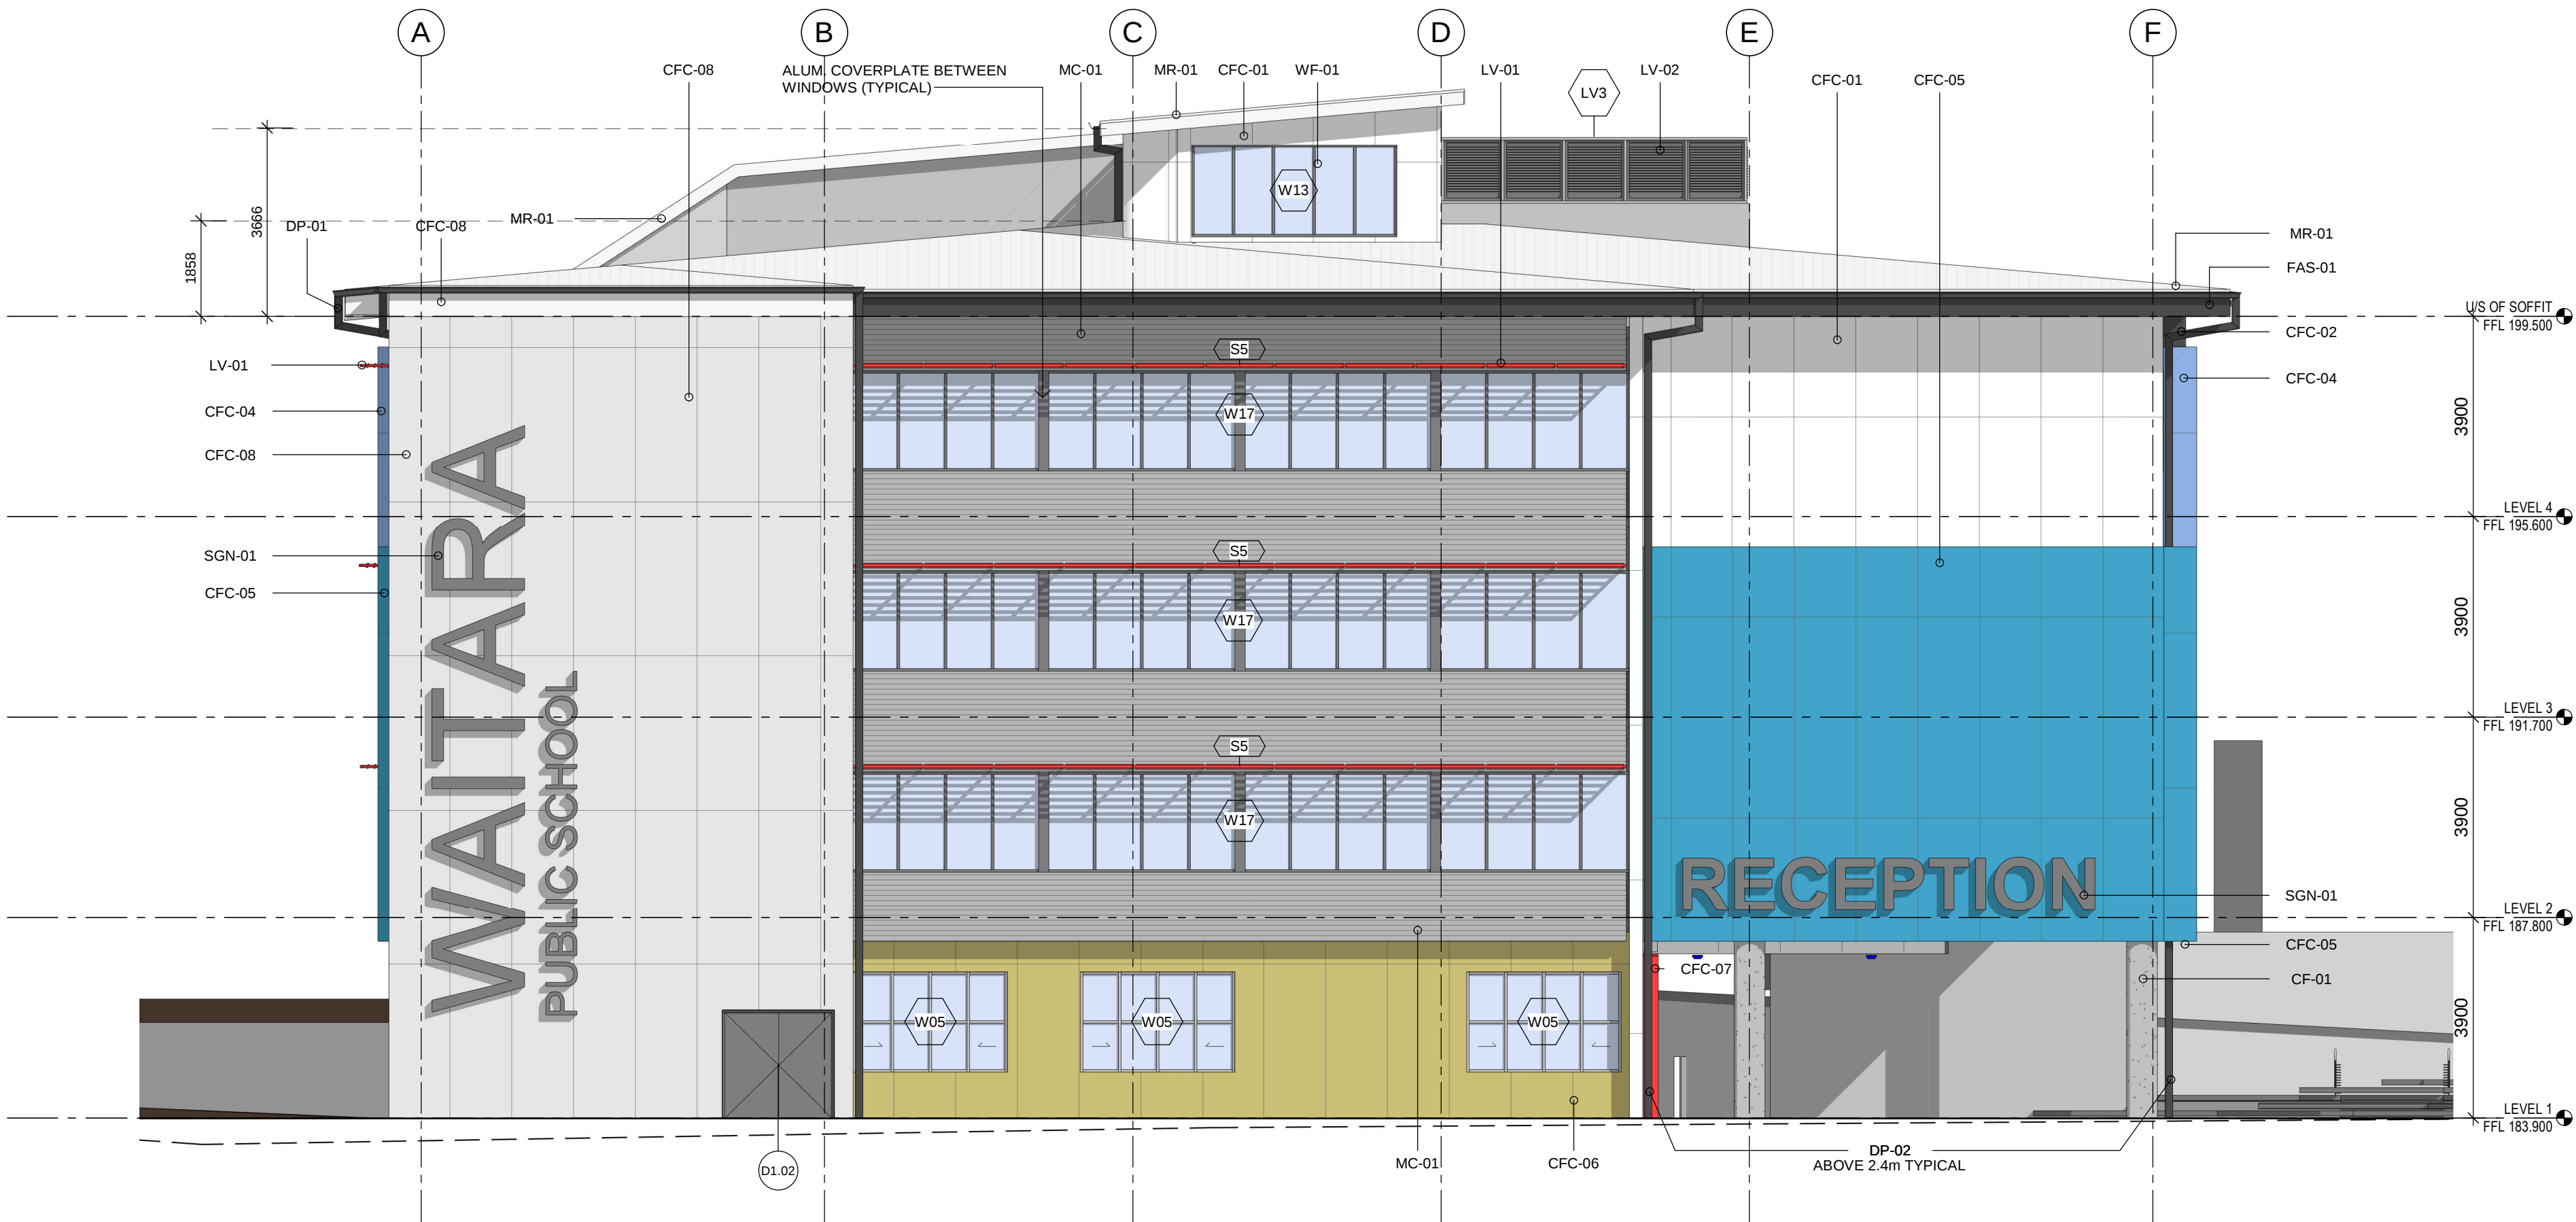

2 West Elevation
1 : 100

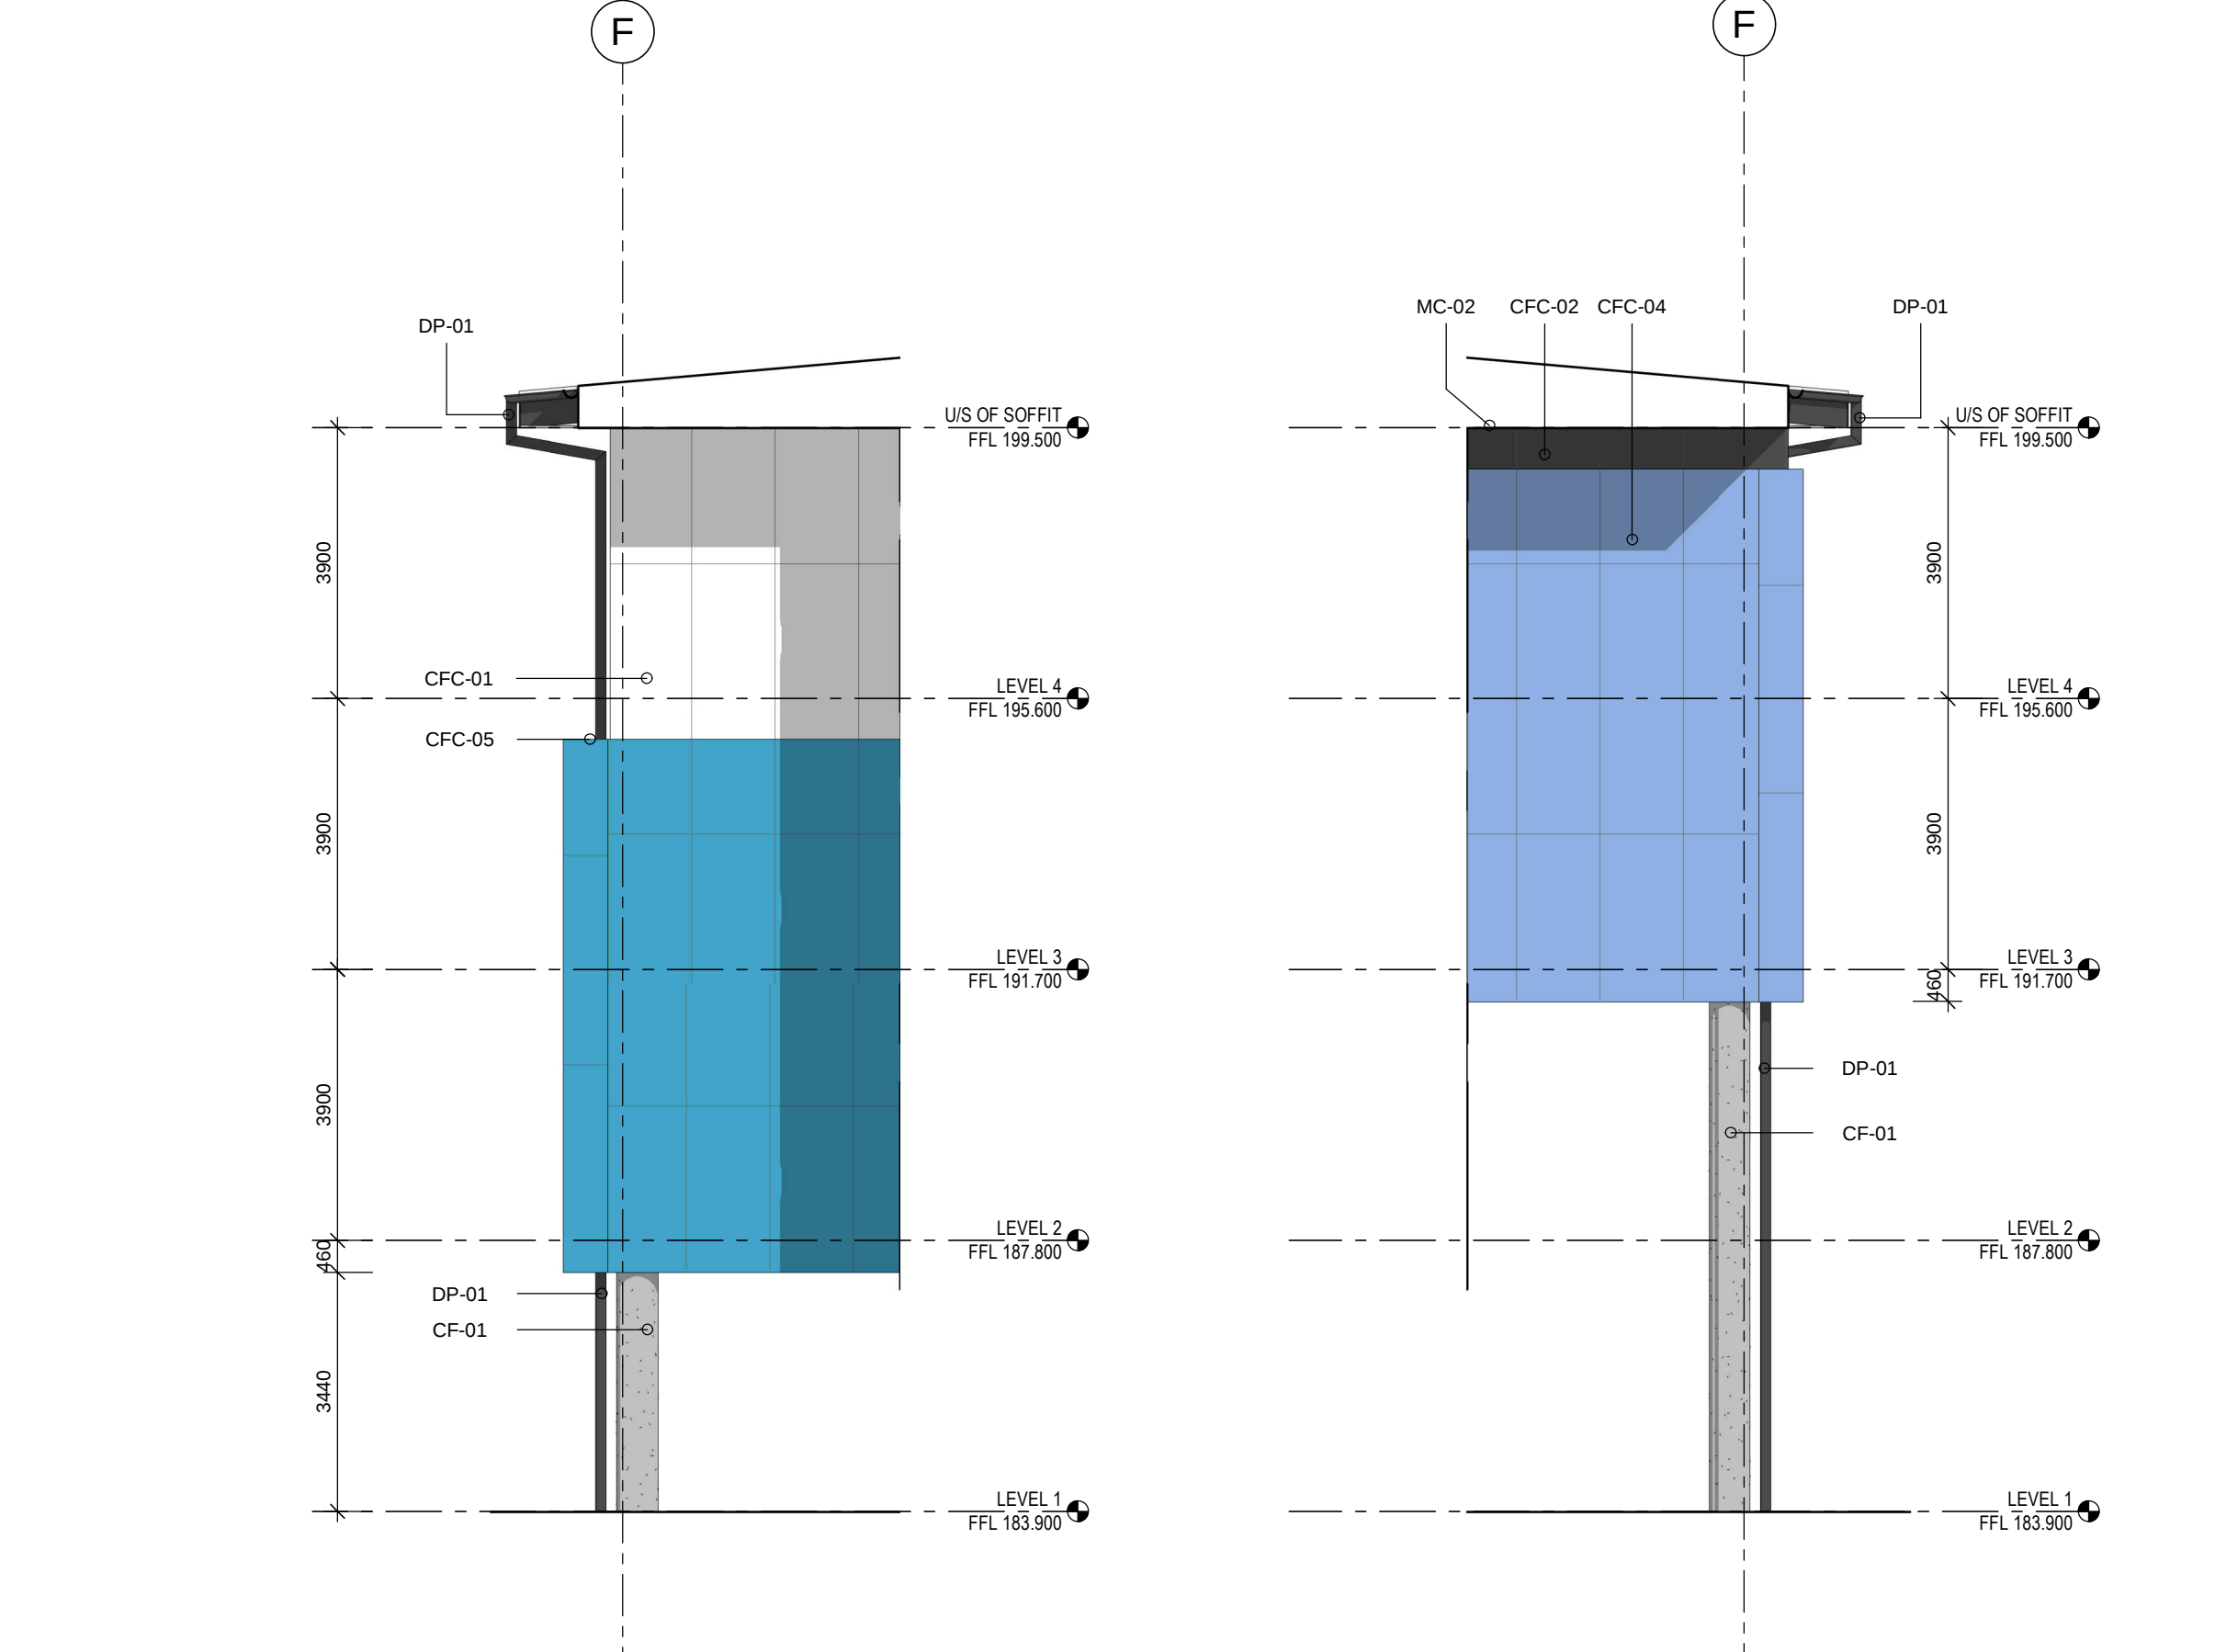

5 East Elevation - Grid 4
1 : 100

6 West Elevation - Grid 5
1 : 100

Issue	No.	Date	Description	Chkd
	A	31/01/2019	For Construction	EK

FOR CONSTRUCTION

CODE	DESCRIPTION
DP-02	EXTERNAL 150 DIA. COLORBOND STEEL DOWNPIPE
FAS-01	PRESSED METAL FASCIA
LV-01	PROPRIETARY SUNSHADE IN A PERIMETER FRAME, RED POWDERCOAT FINISH
LV-02	MECHANICAL PLANTROOM LOUVRE SCREEN
MC-01	SELECTED SPANDEK METAL DECK AS SPECIFIED
MC-02	METAL CLADDING SYSTEM TYPE 2: ALPOLIC COLOUR METALLIC
MR-01	METAL ROOFING ON UNDERLAY AS SPECIFIED
SGN-01	SIGN TYPE 01
WF-01	NARROWLINE 400 ALUMINIUM WINDOW FRAMING - 100 X 45MM BOX SECTION FRAMING WITH CENTRE GLAZING POCKET
W13	INTERNAL 150MM DIA. PVC DOWNPIPE

CODE	DESCRIPTION
DP-02	EXTERNAL 150 DIA. COLORBOND STEEL DOWNPIPE
FAS-01	PRESSED METAL FASCIA
LV-01	PROPRIETARY SUNSHADE IN A PERIMETER FRAME, RED POWDERCOAT FINISH
LV-02	MECHANICAL PLANTROOM LOUVRE SCREEN
MC-01	SELECTED SPANDEK METAL DECK AS SPECIFIED
MC-02	METAL CLADDING SYSTEM TYPE 2: ALPOLIC COLOUR METALLIC
MR-01	METAL ROOFING ON UNDERLAY AS SPECIFIED
SGN-01	SIGN TYPE 01
WF-01	NARROWLINE 400 ALUMINIUM WINDOW FRAMING - 100 X 45MM BOX SECTION FRAMING WITH CENTRE GLAZING POCKET
W13	INTERNAL 150MM DIA. PVC DOWNPIPE

Drawing Title
Elevations

ORIGINAL DESIGN BY GHD WOODHEAD

Project
WAITARA PUBLIC SCHOOL
DEVELOPMENT
at
68 EDGEWORTH DAVID AVENUE, WAHROONGA
for
NSW DEPARTMENT OF EDUCATION

Architect
NBRSPARTNERSARCHITECTURE.
Sydney
61 2 9922 2344
Any form of replication of this drawing in full or in part without the written permission of NBRSPARTNERS Pty Ltd constitutes an infringement of the copyright. A/N 16 002 247 565
Nominated Architects:
Geoffrey Deane 3766; Andrew Duffin; Garry Hoddinett 5286
© 2017

Date 31/01/2019 3:00:37 PM
Scale 1 : 100 @ A1

Drawing Reference
18159-A-WD-30-02 A

© 2017 0 1 2 3 4 5 6 7 8 9 10